



Green – Flume & Solid Discharge  
 Magenta – Water Discharge

Looking South At Elevation

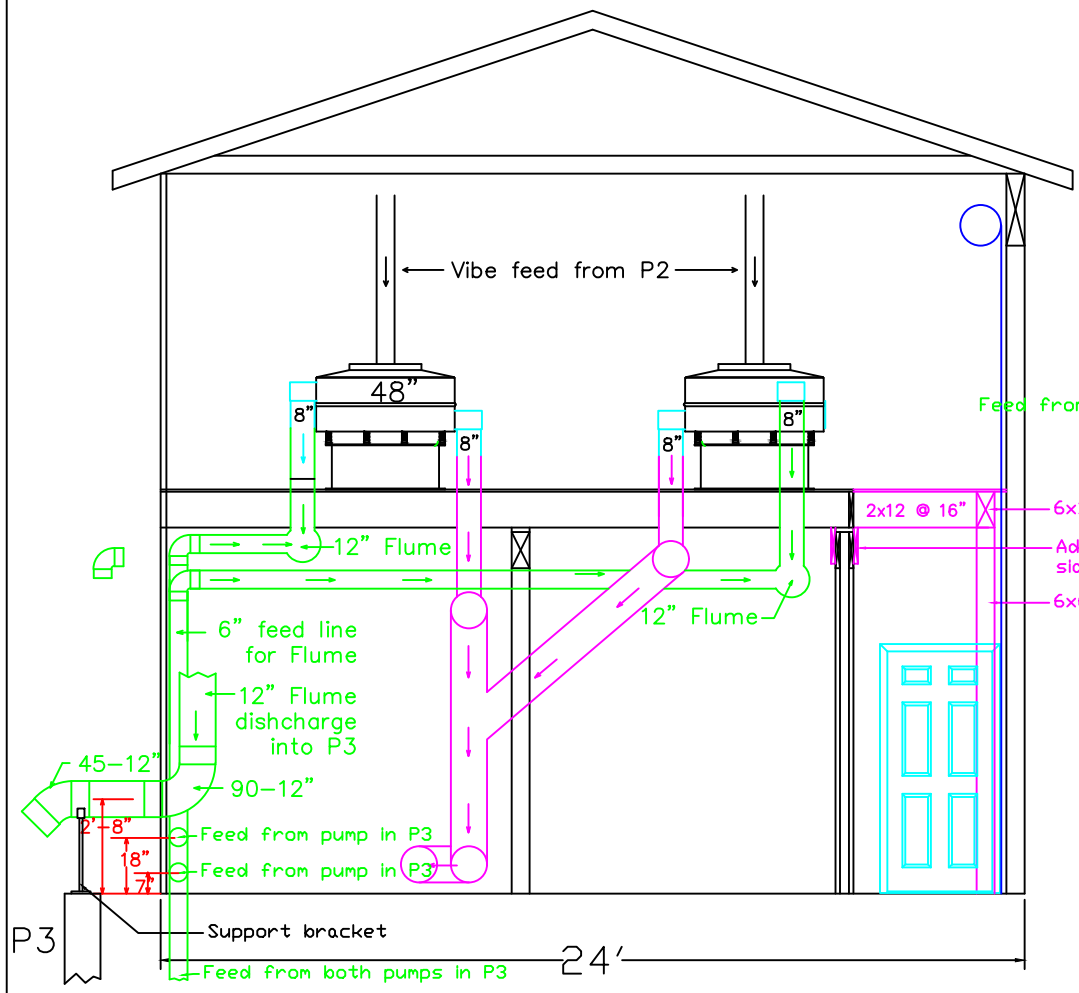


North Elevation

Looking East At Elevation

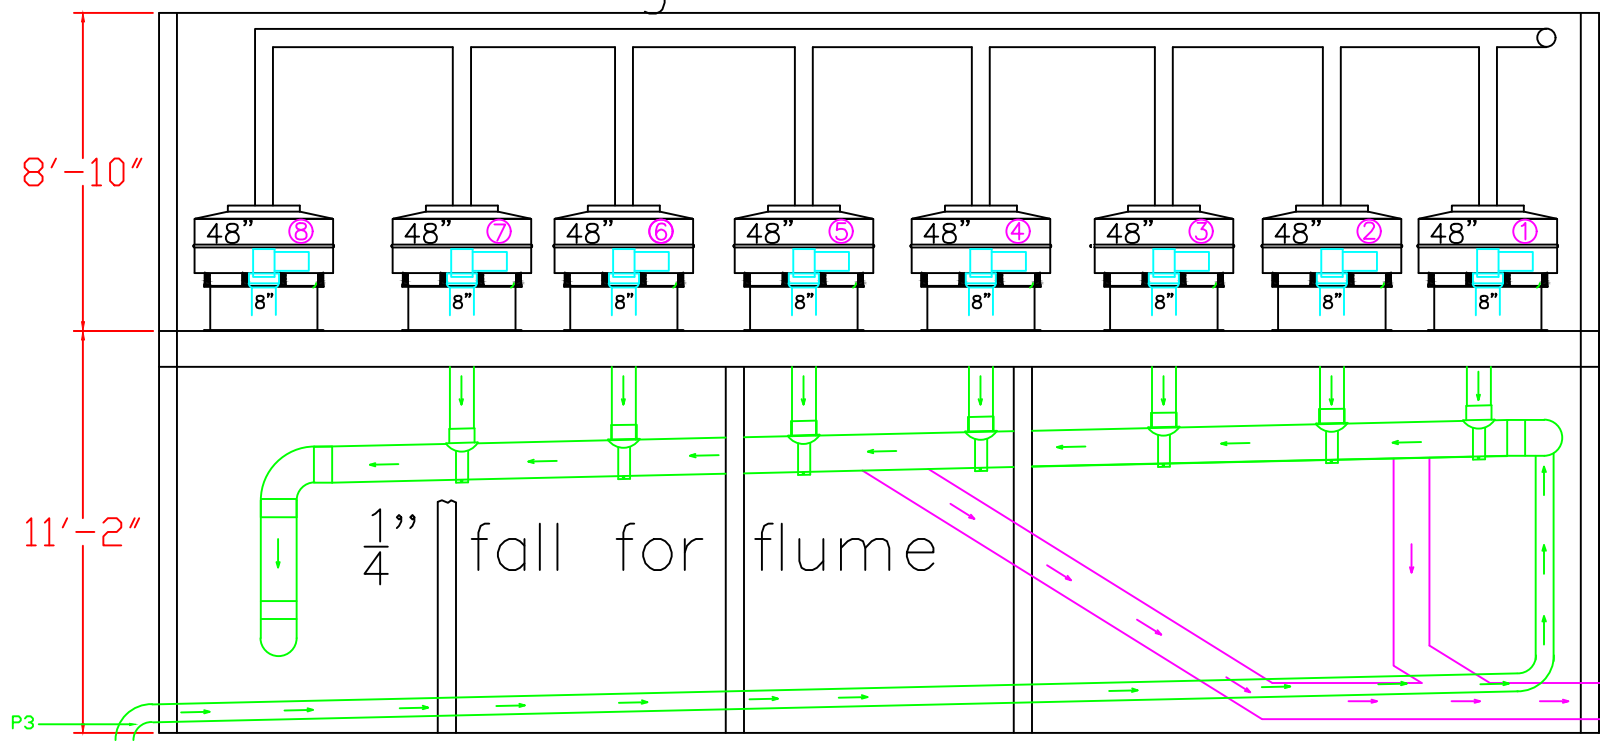

Layout existing 7 vibe screens  
 New flume with feed piping

Looking East At Elevation

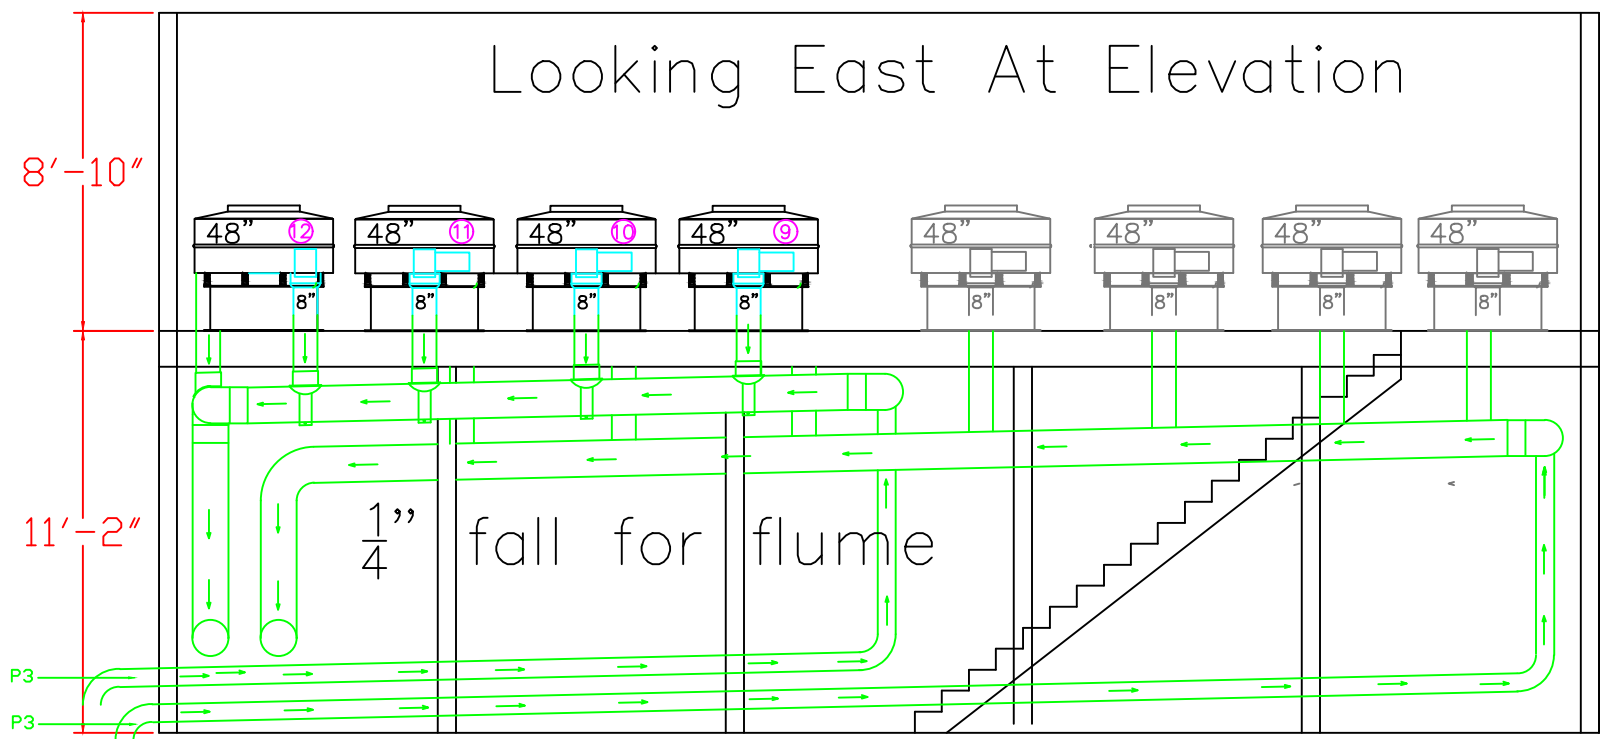

Layout for new vibe screens plus  
 flume with feed piping

11x17

Flume layout  
 cross section

Date  
 Sept. 26, 2024

Stauffer Farms LF-1  
 Manure Thickening Project  
 North Lawrence, NY

Nutrient Control Systems Inc  
 717-261-5711

Contact Person, Lantz Sourbier  
 This document contains Proprietary  
 and confidential information

Scale  
 3/16" = 1'

Page#  
 3

THESE PLANS ARE FOR REVIEW ONLY